


01 Existing Floor Plan
SCALE: 1/8"=1'-0"

area calculations :

-- DENOTES SPACE LEASE LINE

TOTAL OVERALL LEASABLE SPACE SQUARE FOOTAGE = 1,010 S.F.

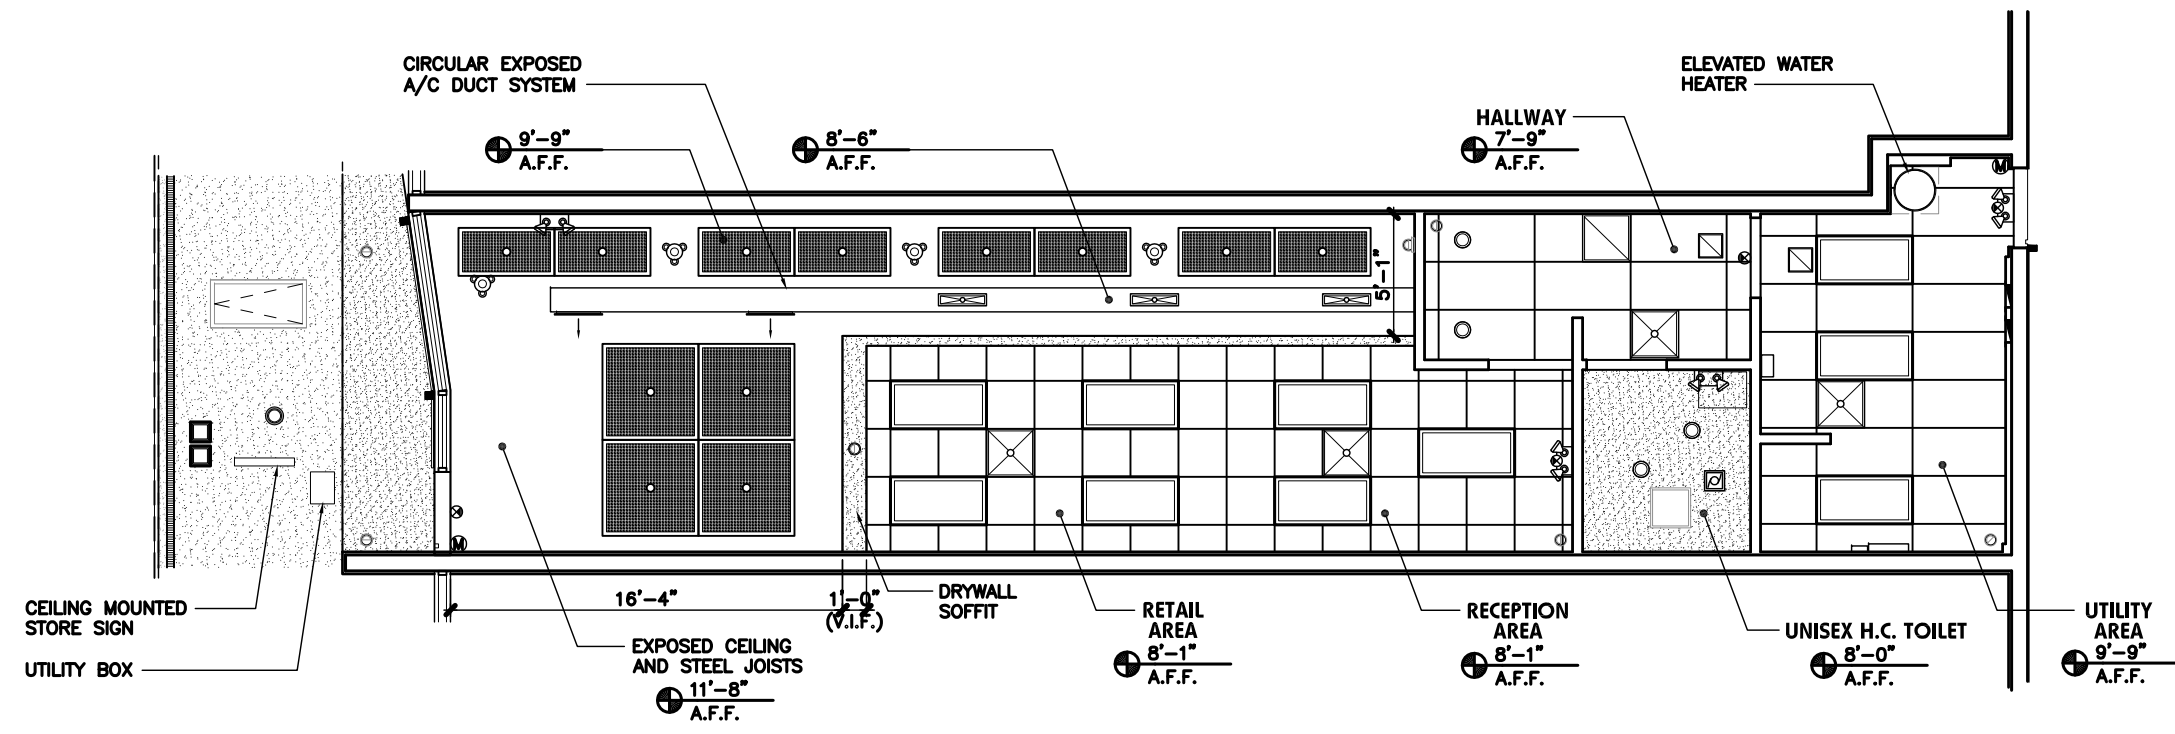

02 Existing Reflected Ceiling Plan
SCALE: 1/8"=1'-0"

- ceiling legend :**
- SECURITY CAMERAS
 - RECESSED LIGHT FIXTURES
 - SUSPENDED LIGHT FIXTURES
 - ⊗ EXIT SIGNS
 - EXIT SIGN/EMERGENCY LIGHT COMBINATION
 - EMERGENCY LIGHT
 - A/C SUPPLY GRILLES
 - A/C RETURN GRILLES
 - CEILING ACCESS PANEL
 - 2' x 4' FLUORESCENT LIGHT FIXTURE
 - CEILING SCREEN PANELS
 - 2' x 2' OR 2' x 4' CEILING TILE AND GRID
 - DRYWALL CEILING
 - CONTINUOUS CEILING VENT
 - MOTION DETECTOR



Suniland Shopping Center
Metro PCS Interior As-Built
11401 S. Dixie Highway
Pinecrest, Florida 33156

project no. :
#16174
date :
10-03-2016
sheet number :
A-1

MODIS Architects, LLC
4955 SW 75th Avenue
Miami, Florida 33155
t. 786.879.8882
f. 786.350.1515
w. www.modisarchitects.com

